

LIGHTING

Designed & installed by Agile Courts.




Carefully designed lighting plans to illuminate your court for optimum play at night.

8 x 600 watt LED's for high output lighting that requires fewer poles and fixtures per court.

Single, Double or Quad and 180 degree lighting fixtures available.

All aluminum construction, powder coated for a professional finish.

Our systems exceed South Florida Hurricane Codes.

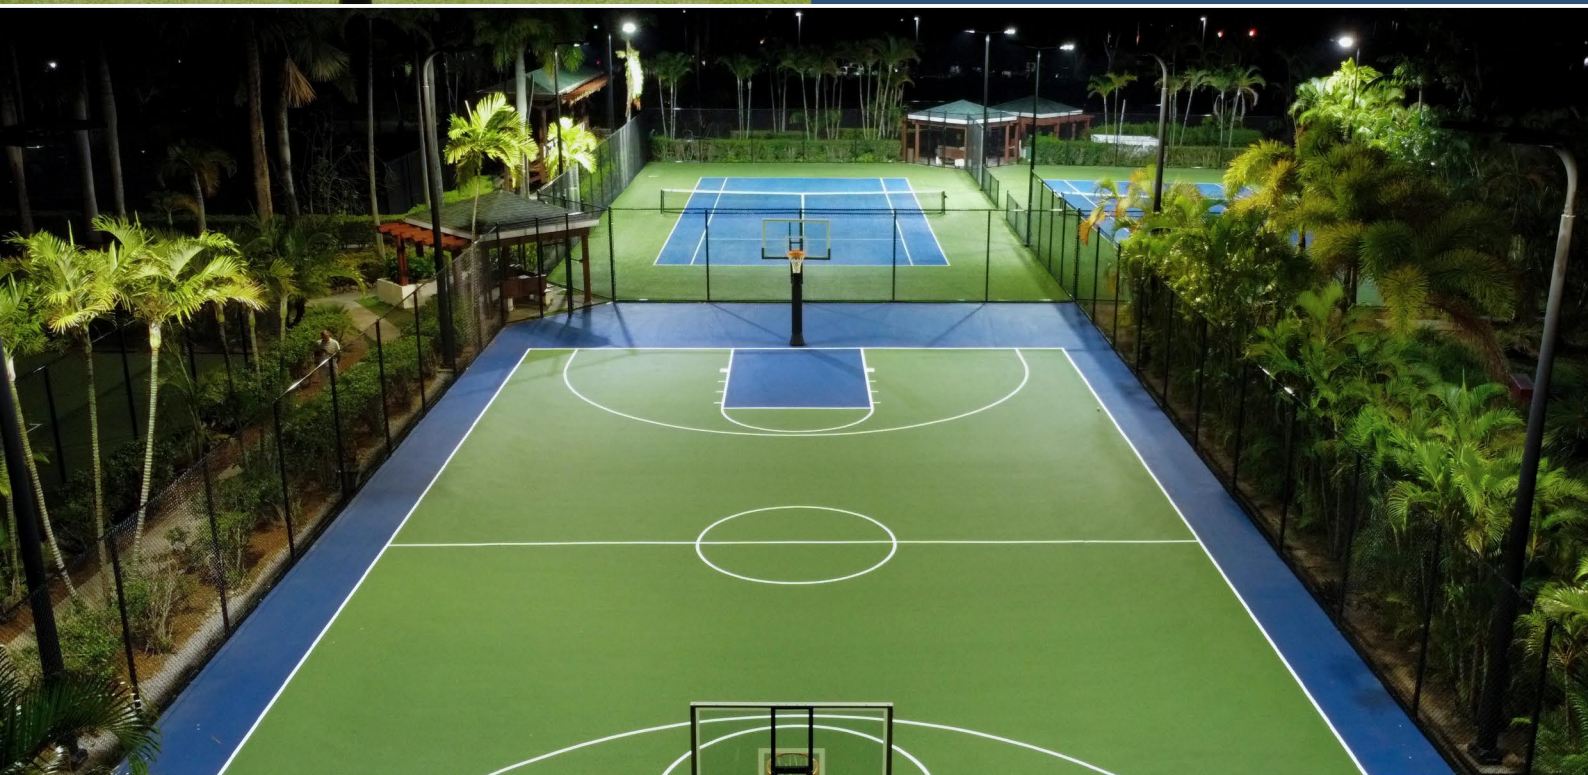



Lighting Features

Watt	CCT	Lumen	Input Frequency	Voltage	Warranty
600W	2700-7000k	90000lm	50/60HZ	100-277V	5 Years

Power Factor: ≥ 0.95

LED Chip: 5050

CRI: Ra ≥ 70

Dimming: Available

Motion Sensor: Available

Day/Night Sensor: Available

Material: Aluminum alloy + PC optic lens


Standard color: Black/White/Dark bronze

Working Temperature: -40°F ~ 122°F

Lifespan: 54000 hours (@Tc = 176°F)



Total Harmonic Distortion: 15%

AC180-AC528V available

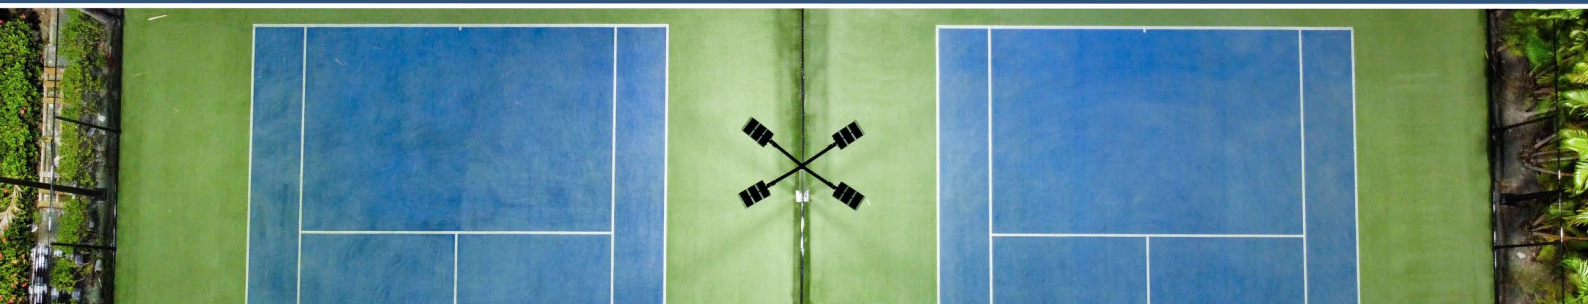

Sports Court Lighting Plan.


Values in Lux. Scale 1 : 262

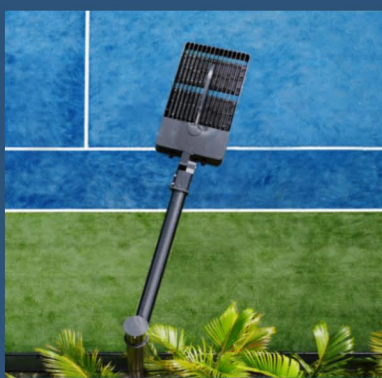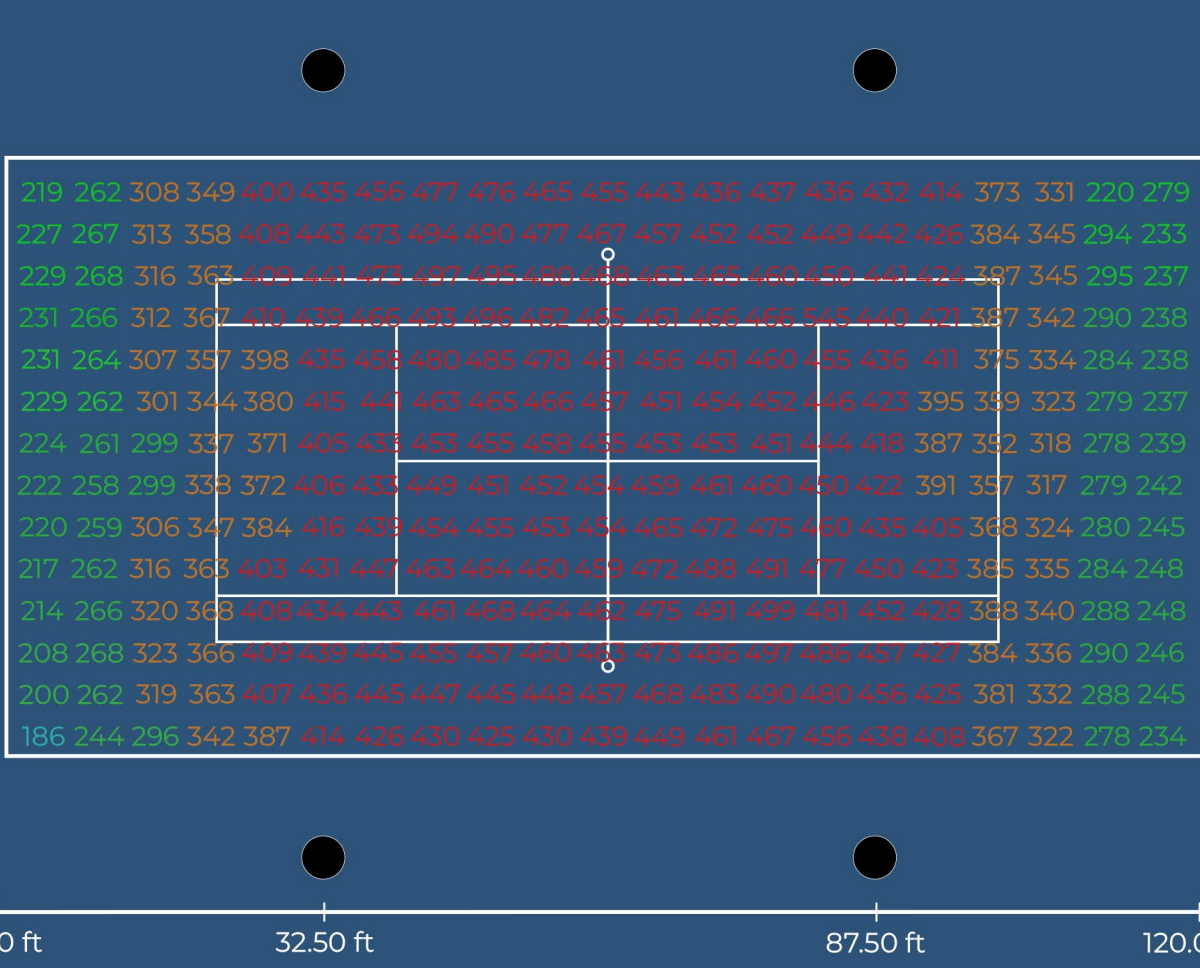


Single



Double

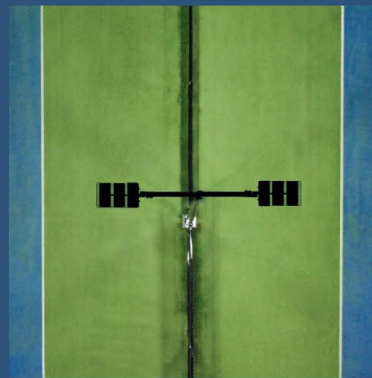

180°

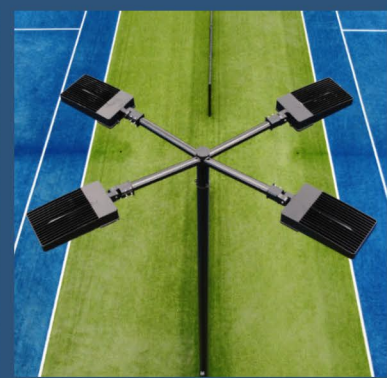

Quad